


HYDRANTS #1, #3 & #4
REFER TO STD. NO. S-9

HYDRANT #2 ADD A 4" IN LINE
GATE VALVE TO THE MAIN LINE
REFER TO STD. NO. S-9 DETAIL

SITE PLAN
SCALE 1" = 200'

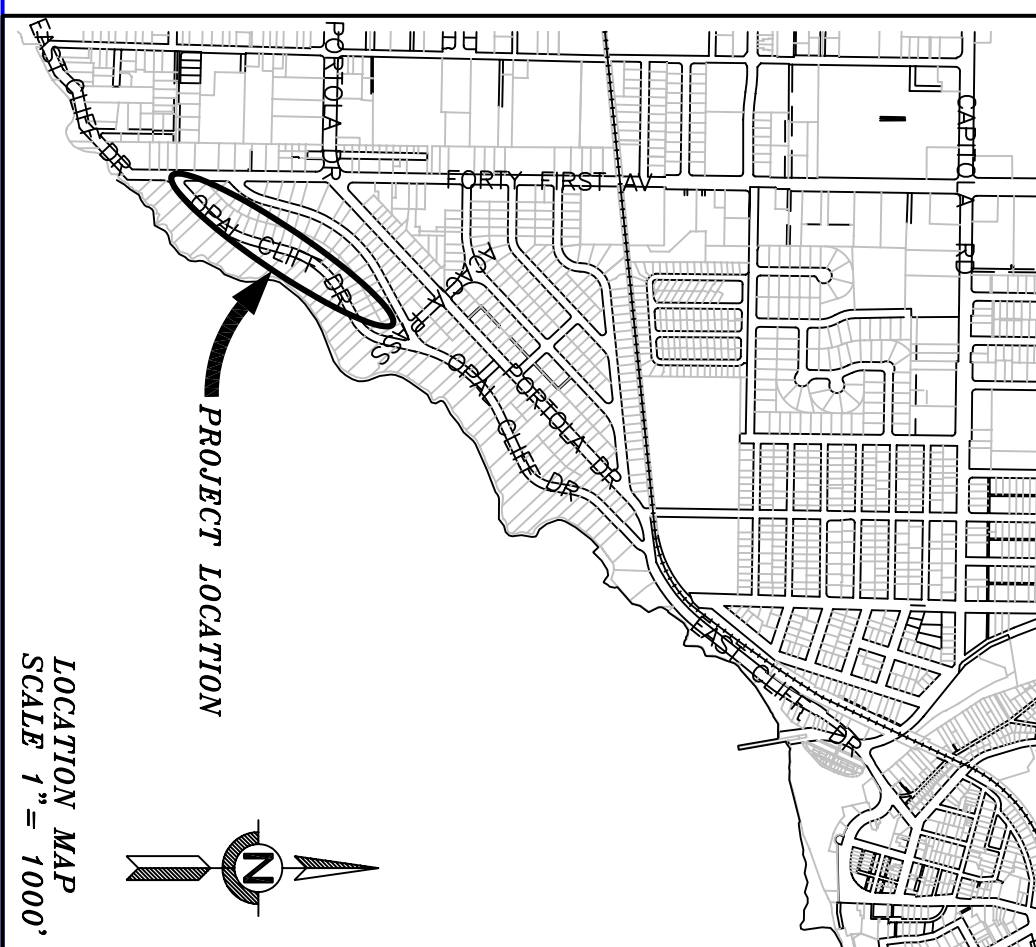


PROJECT LOCATION

LOCATION MAP
SCALE 1" = 1000'

OPAL CLIFF WHARF HEAD VALVE INSTALLATION

SOQUEL, SANTA CRUZ COUNTY, CALIFORNIA

No.	Revision/Issue	Date
TAD	ISSUED FOR REVIEW	06/16/03
0	ISSUED FOR CONSTRUCTION	XX/XX/XX

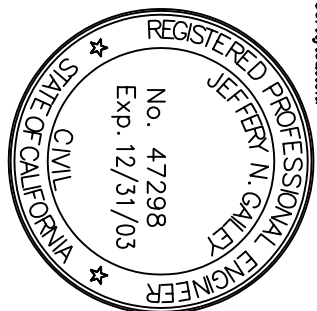

Jeffery N. Galey
Chief Engineer
Engineering Manager

SOQUEL CREEK WATER DISTRICT
 P.O. Box 158, Soquel, California 95073
 Phone Number: (831) 475-8500
 Fax Number: (831) 475-4291

DESIGNED BY: CCC
 DWG. NO. B-03-2123-H

CERTIFICATION: SHEET **B-1**

SCALE: AS NOTED
 DATE: 08/03/03

REVIEWED BY: O.&M.
 DATE: _____