


# SOQUEL CREEK WATER DISTRICT

## SOQUEL DRIVE CAST IRON MAIN REPLACEMENT PROJECT

### PHASE I & II

### SOQUEL, CALIFORNIA

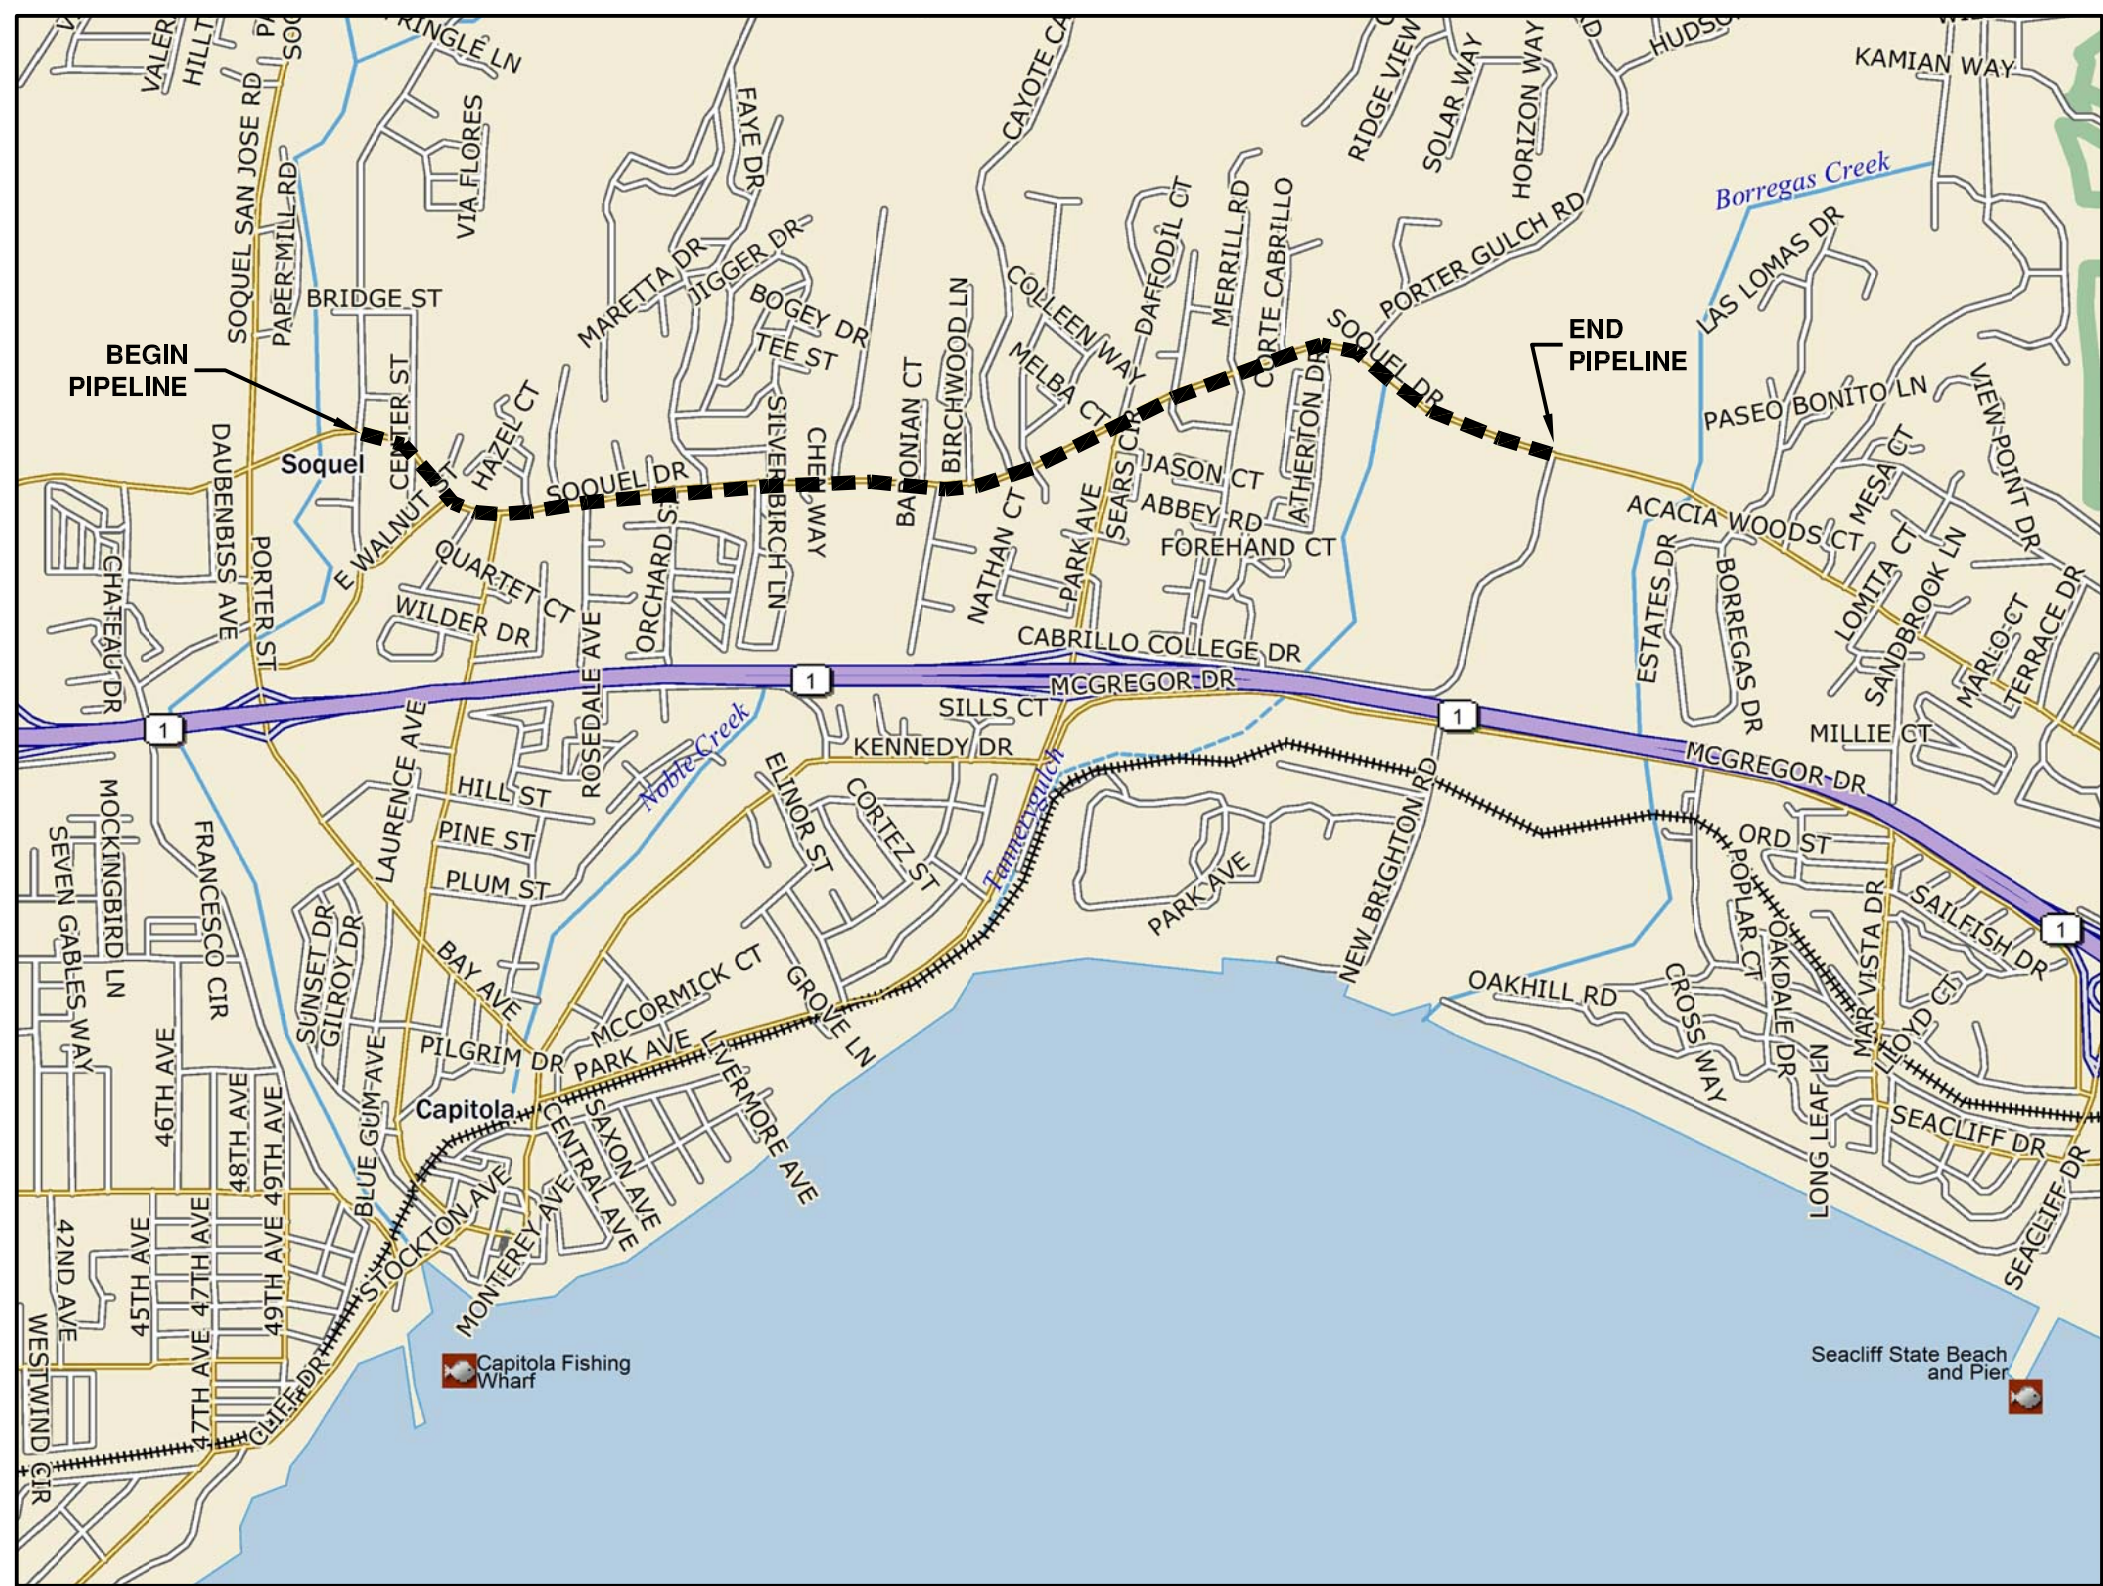

**LOCATION MAP**  
NO SCALE

**SHEET INDEX**

1	TITLE SHEET
2	NOTES, ABBREVIATIONS, LEGEND & SHEET LAYOUT
3 - 17	SITE PLAN & PROFILE
18	ADDITIONAL PLAN & PROFILE, DISINFECTION PLAN & ENCROACHMENT
19	DETAILS

SOQUEL CREEK WATER DISTRICT

APPROVED BY: ENGINEERING MANAGER \_\_\_\_\_ DATE \_\_\_\_\_

NO	REVISIONS	DATE	APPR
1			
2			
3			
4			
5			

**SOQUEL CREEK WATER DISTRICT**  
 PO Box 1550, Capitola, California 95010  
 Phone Number: (831) 475-8500  
 Fax Number: (831) 475-4291  
**CWO 11-128 & 11-129**

**Schaaf & Wheeler**  
 CONSULTING CIVIL ENGINEERS  
 3 Quail Run Circle, Suite 101  
 Salinas, CA 93907-2348  
 (831) 883-4848



**SOQUEL DRIVE CAST IRON MAIN REPLACEMENT PROJECT, PHASE I & II**  
**TITLE SHEET**

DATE: 9/18/12  
 SCALE: AS SHOWN  
 DESIGN: LJK, JCT  
 DRAWN: LJK  
 CHECKED: AAS

**SHEET**  
**1**  
 OF  
**19**